



SEE SHEET M-5
FOR STRUCTURAL
PLATFORM FOR
CU-1B & CU-2.

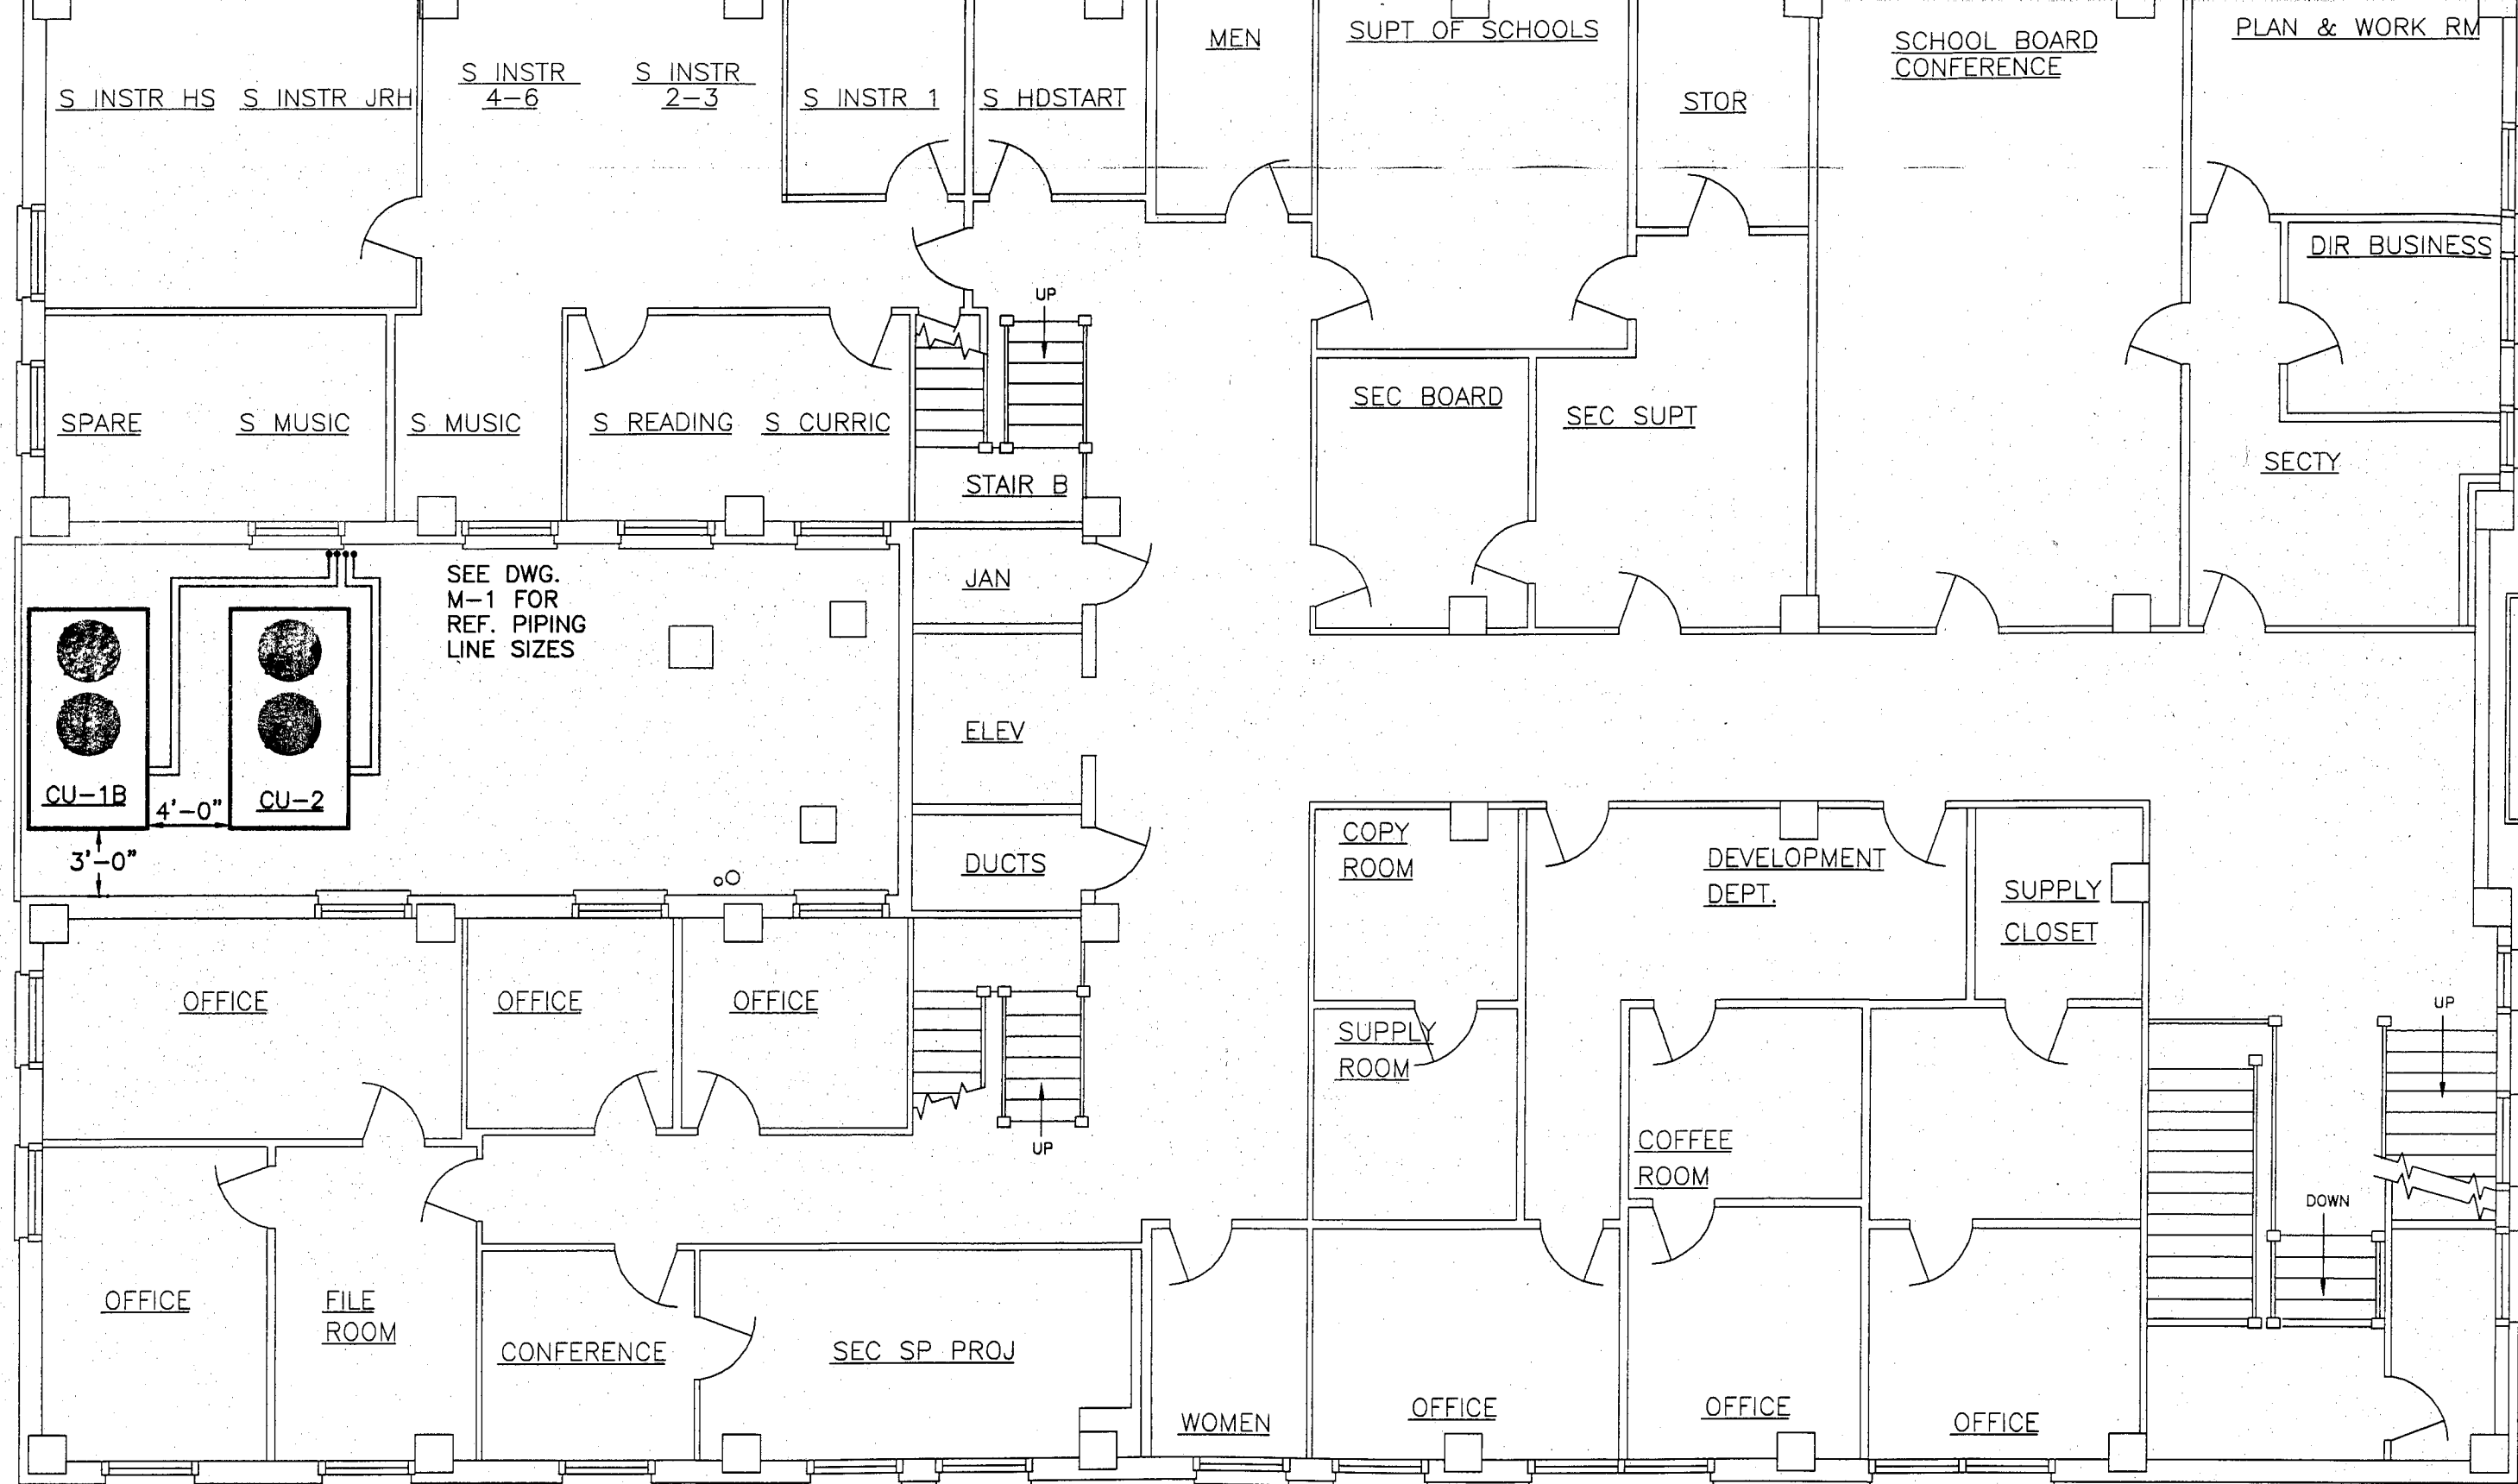


SECOND FLOOR MECHANICAL PLAN

SCALE : 1/8" = 1'-0"

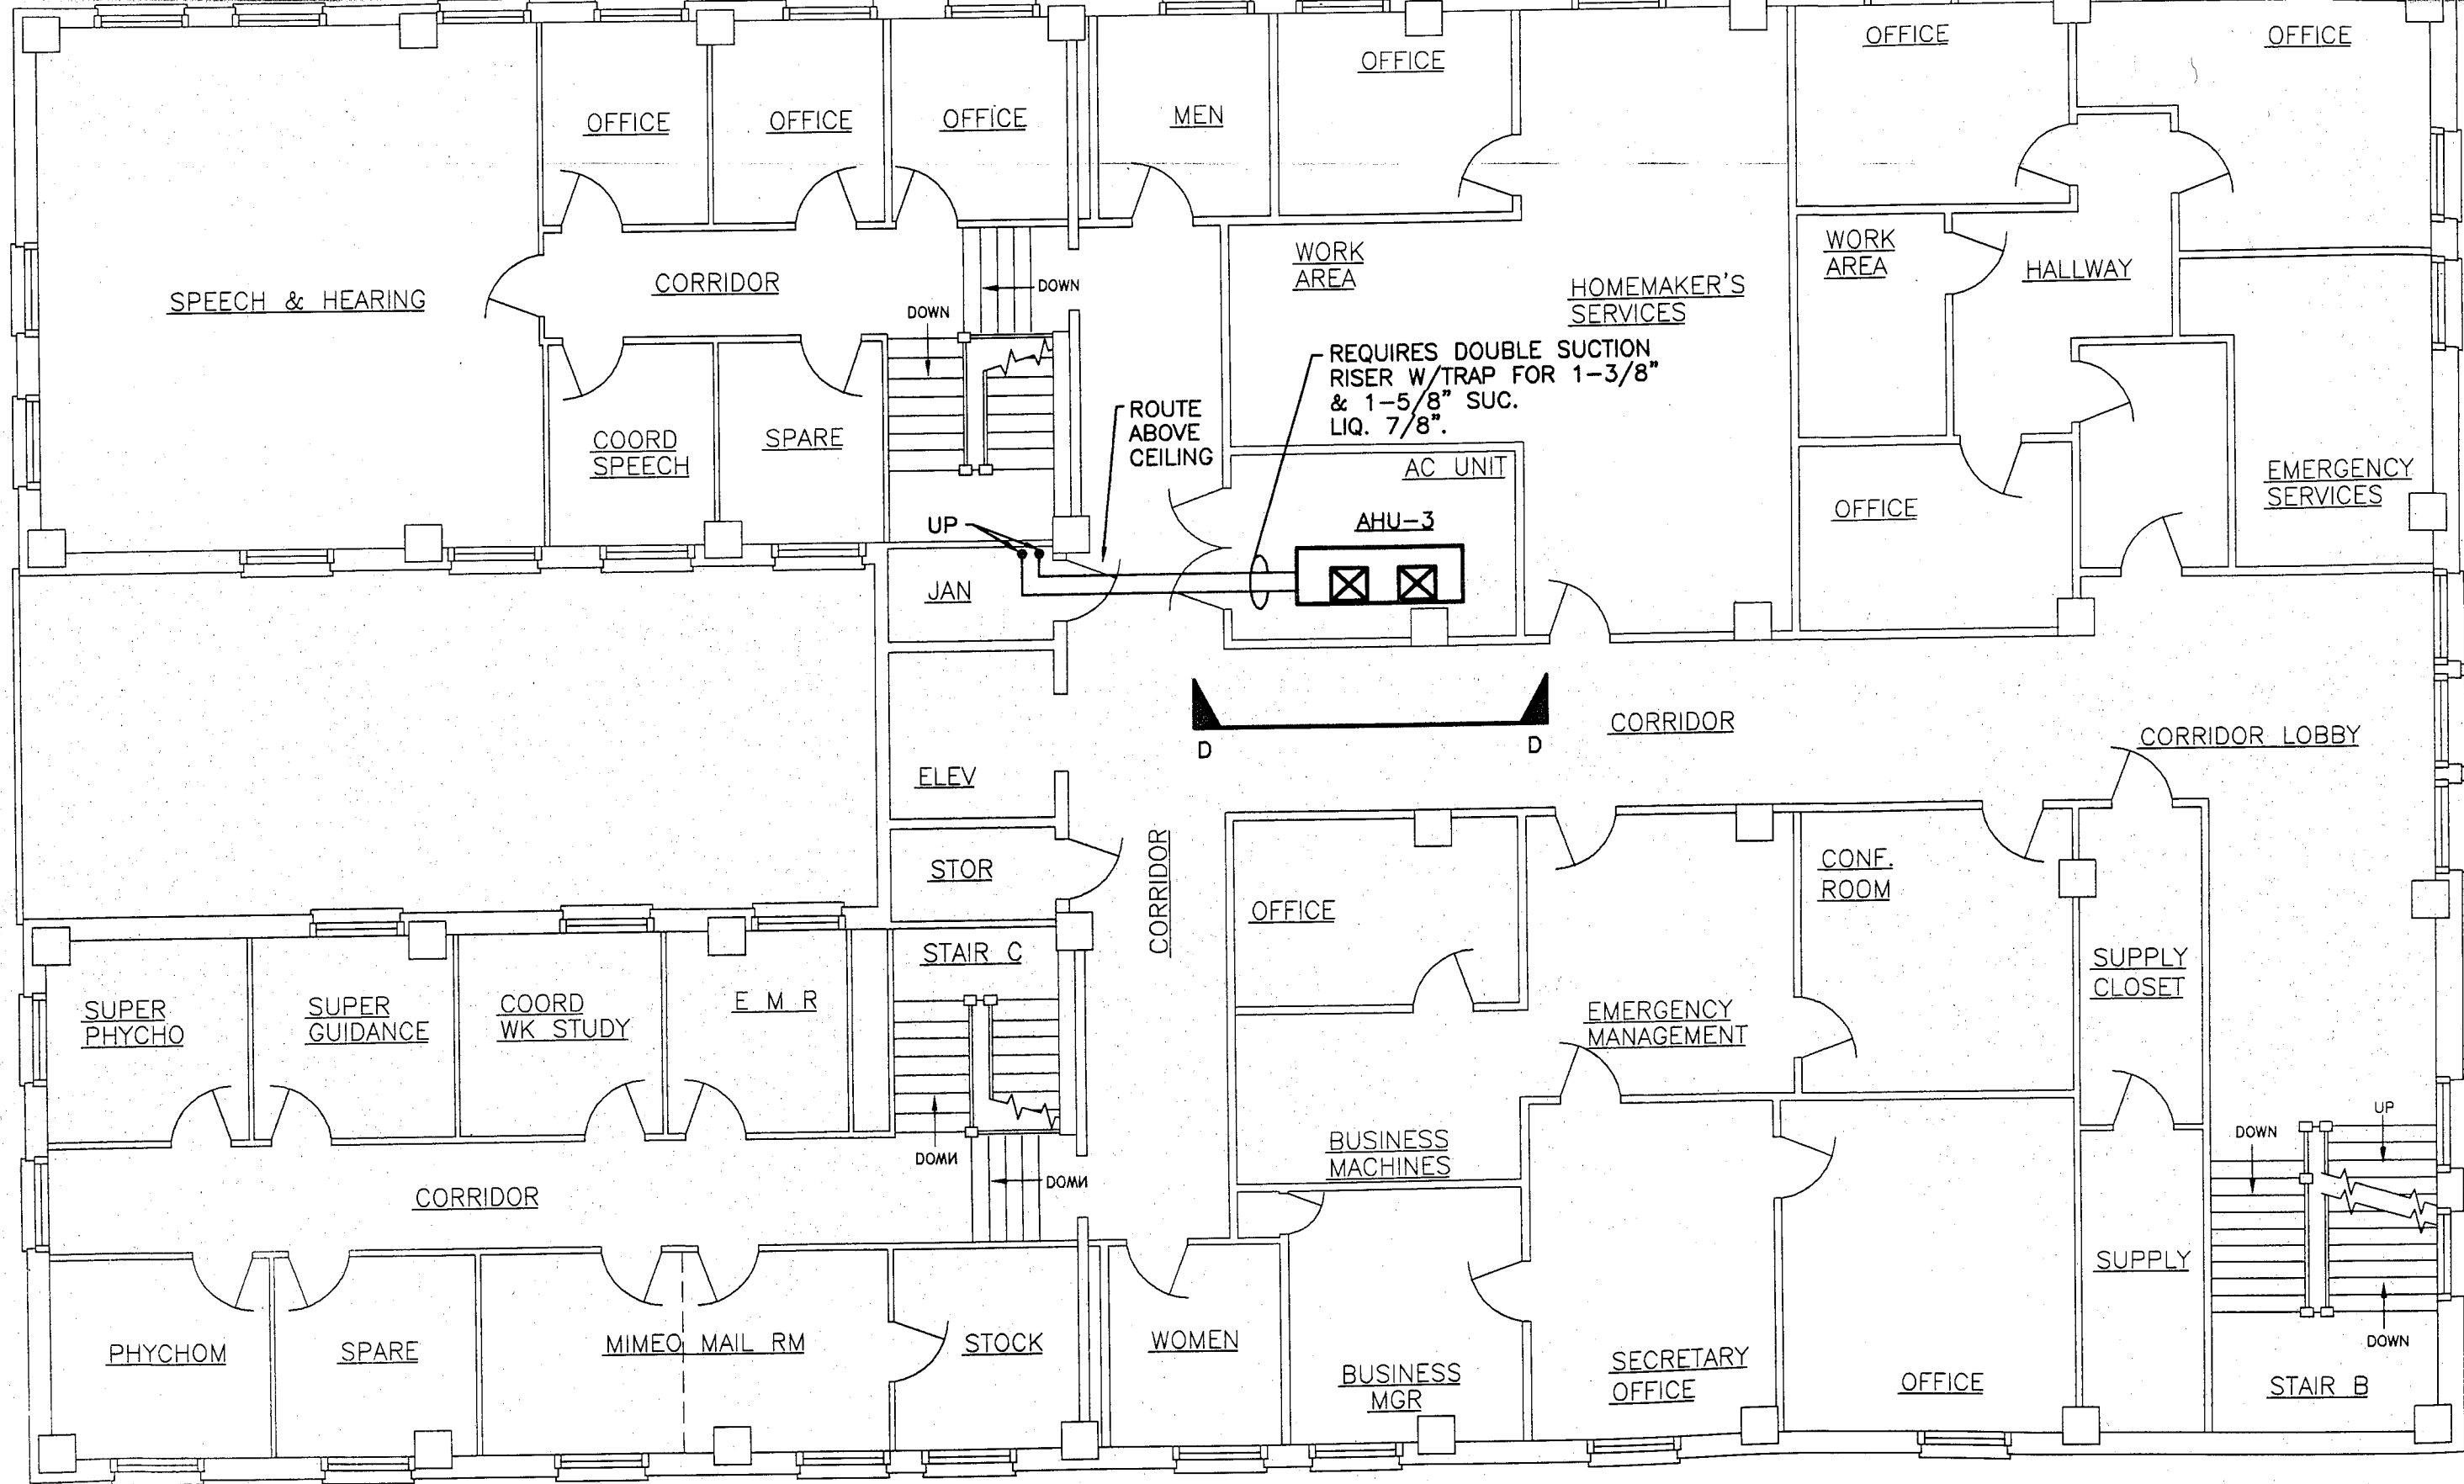

THIRD FLOOR MECHANICAL PLAN

SCALE : 1/8" = 1'-0"

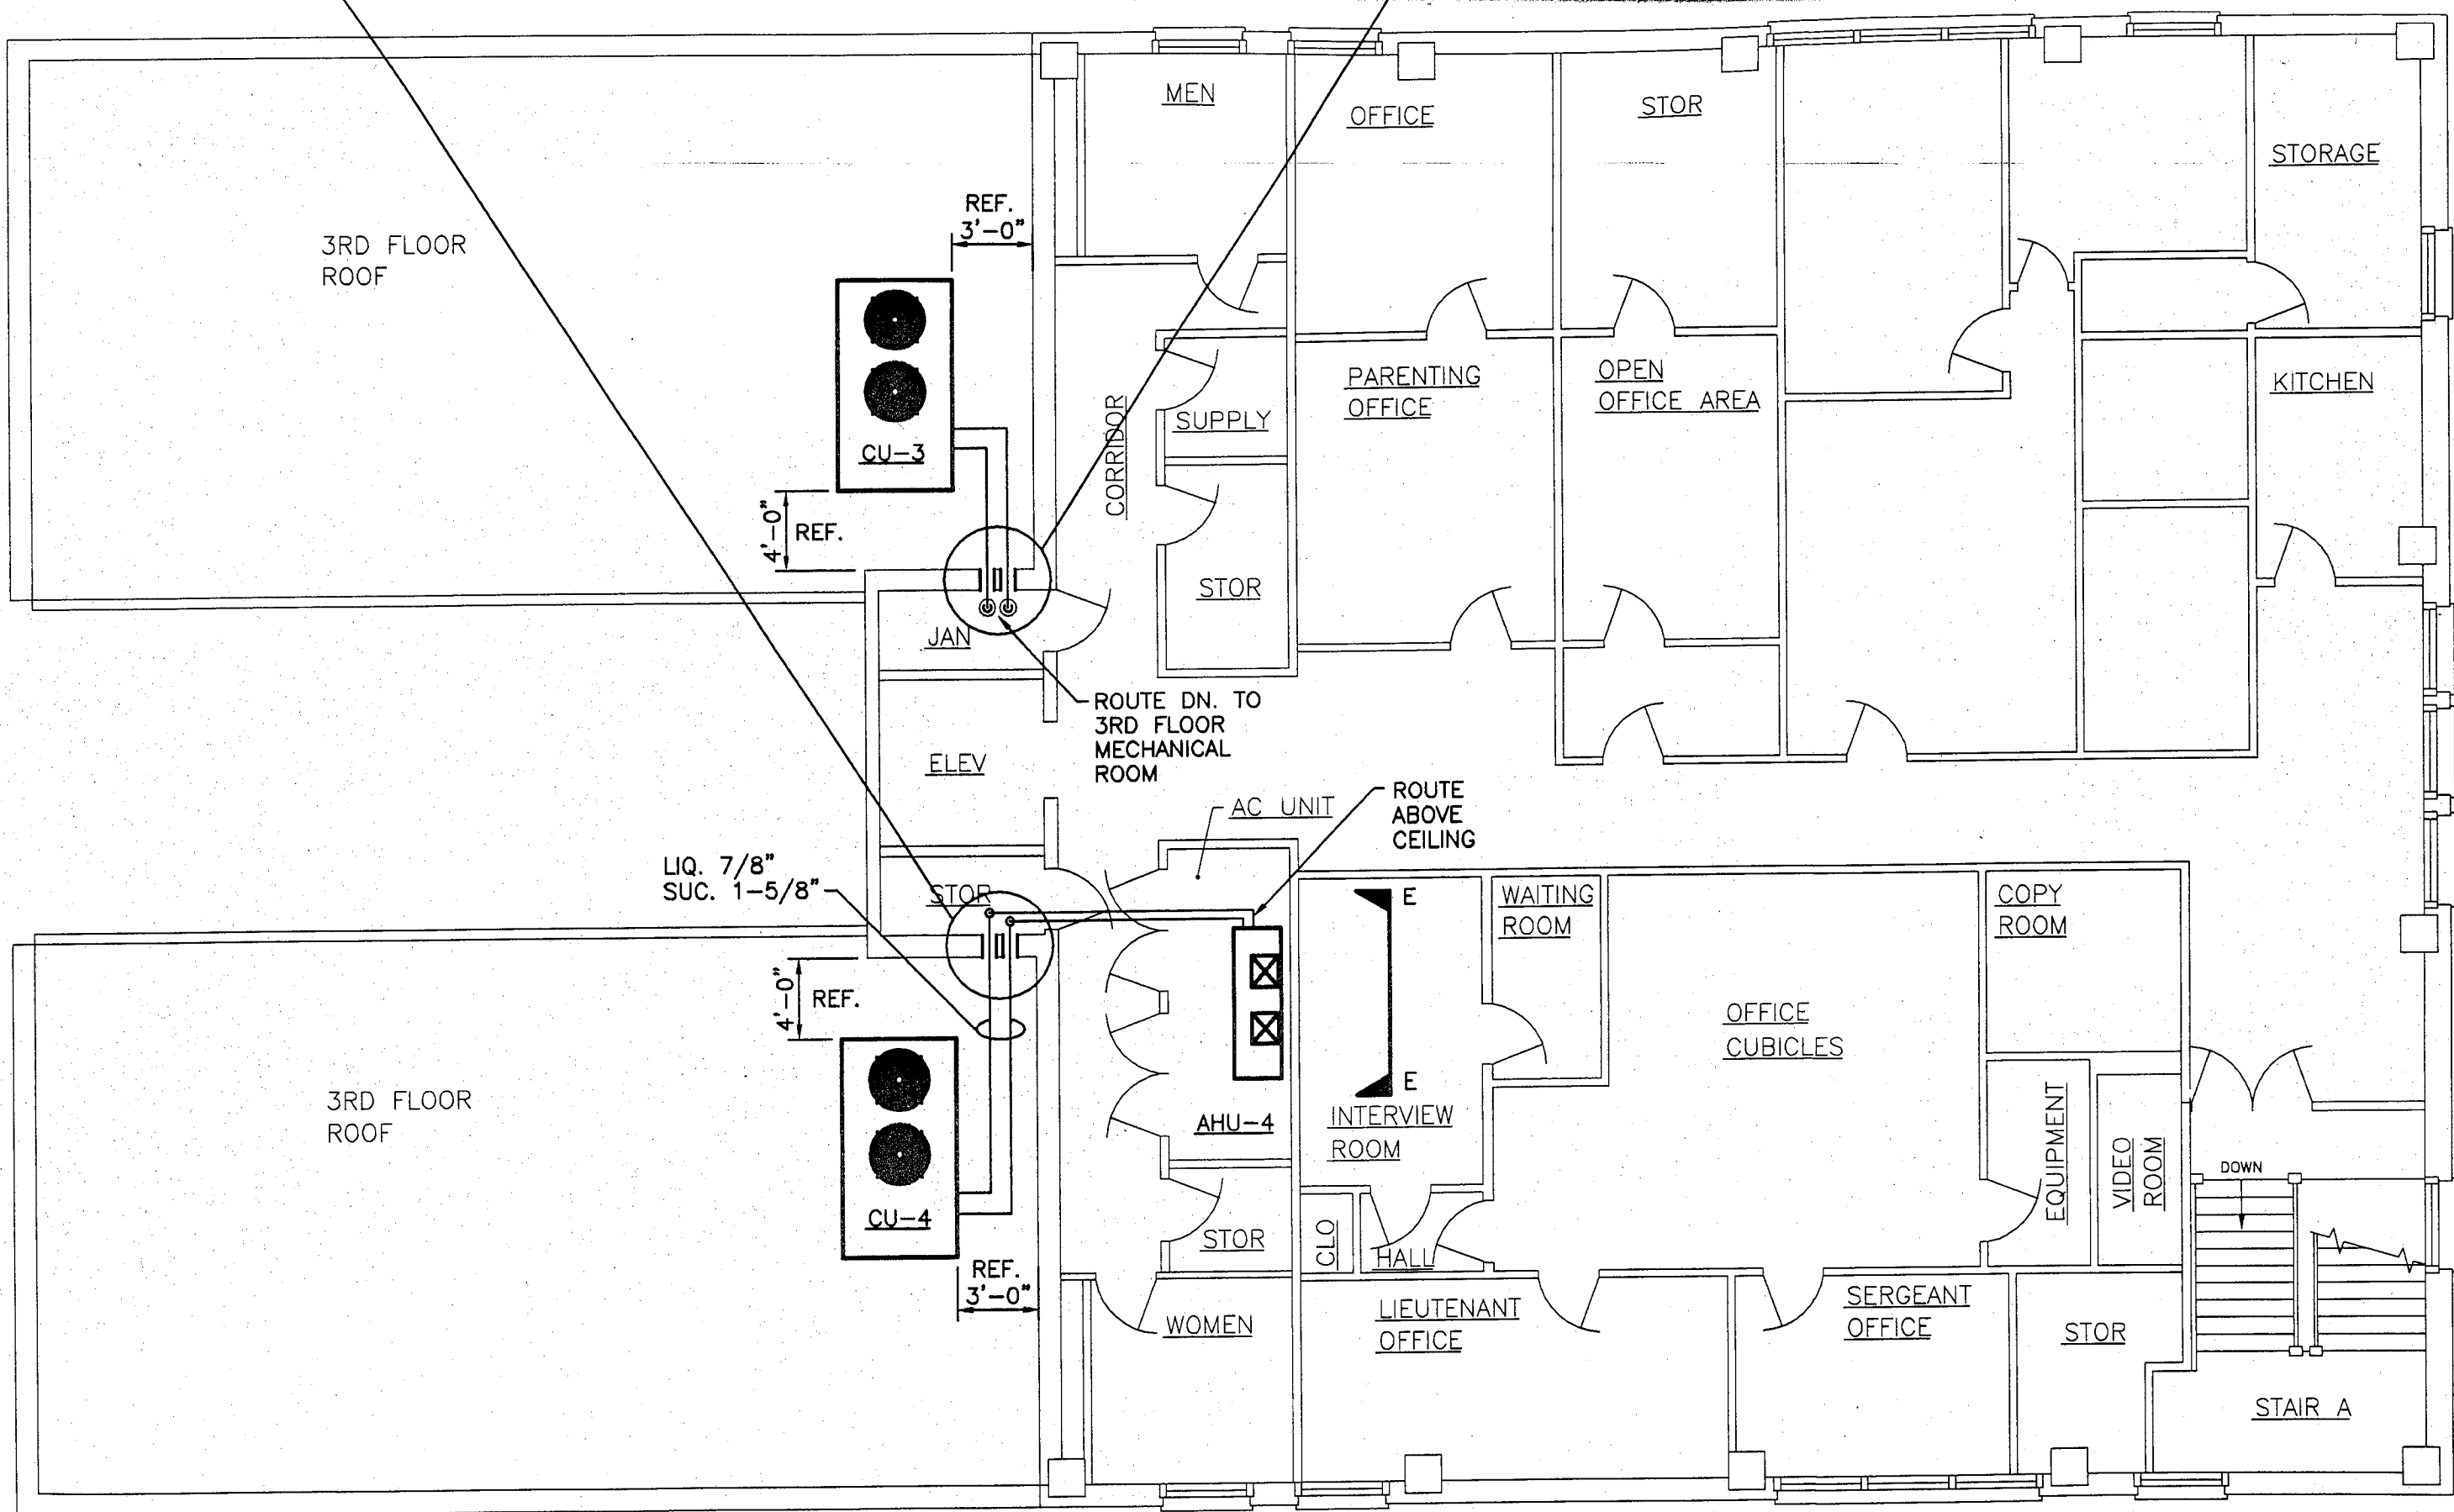

FOURTH FLOOR MECHANICAL PLAN

SCALE : 1/8" = 1'-0"