


SECOND FLOOR PLAN

AS-BUILT  
 RECORD  
 DRAWING  
 10/11/2004

**tyco** / Fire & Security / **SimplexGrinnell**  
 3200 N. HAWTHORNE STREET  
 CHATTANOOGA, TN. 37406  
 SALES: 423-698-4418  
 SERVICE: 423-698-4418  
 FAX: 423-698-5979  
 © 2001 SIMPLEX GRINNELL

NO.	DATE	REVISION DESCRIPTION


FIRE ALARM SYSTEM MLK BUILDING 317 OAK STREET CHATTANOOGA, TN. 37402		HAMILTON COUNTY FIRE ALARM UPGRADE	
DRAWN BY: RICHARD SMITH	DATE: 08/09/2004	PROJECT NUMBER: 288-401749 855790001	SECRET NUMBER: FF01-B
APPROVED BY: RICHARD SMITH	DATE: 08/09/2004	SECRET TITLE: FIRE ALARM SECOND FLOOR	SECRET NUMBER: FF01-B
APPROVED BY:	DATE:	SECRET NUMBER:	SECRET NUMBER:

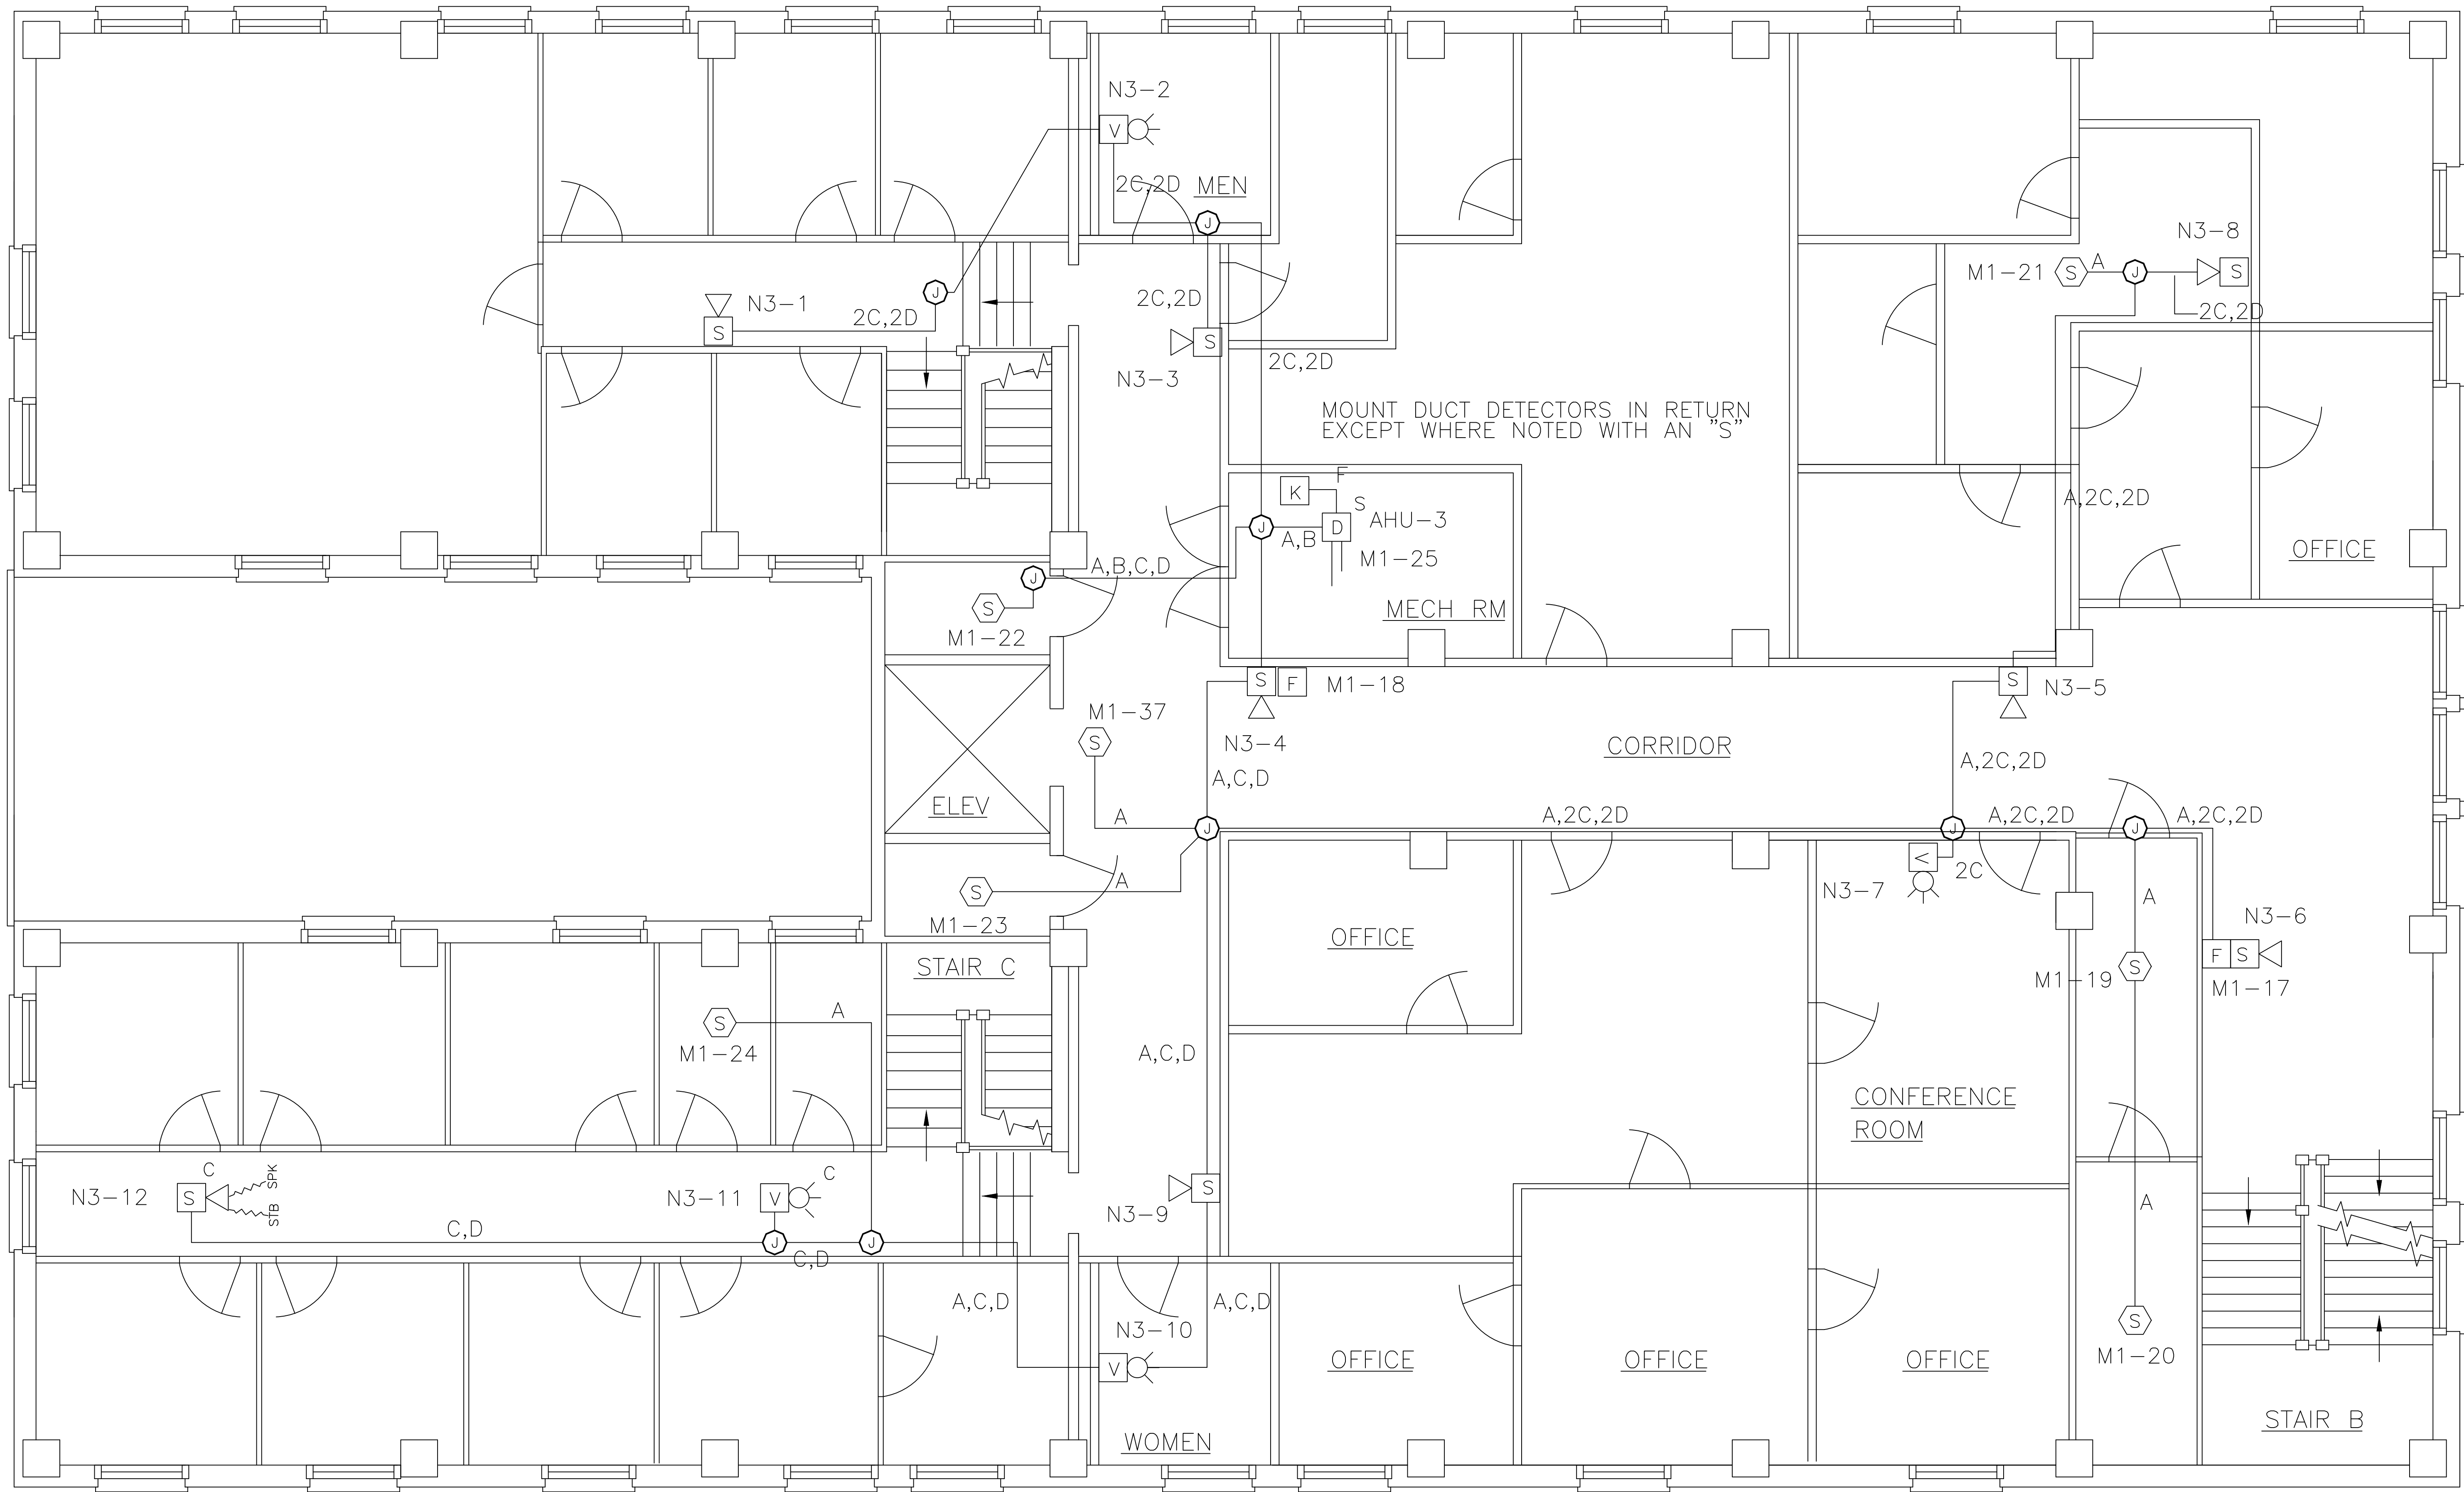

THIRD FLOOR PLAN

AS-BUILT  
RECORD  
DRAWING  
10/11/2004

<p><b>tyco</b> / Fire &amp; Security / <b>SimplexGrinnell</b></p> <p>3200 N. HAWTHORNE STREET CHATTANOOGA, TN. 37406</p> <p>SALES: 423-698-4418 SERVICE: 423-698-4418 FAX: 423-698-5979</p>	
REVISION DESCRIPTION	
DATE	
NO.	
<p>FIRE ALARM SYSTEM MILK BUILDING 317 OAK STREET CHATTANOOGA, TN. 37402</p> <p>HAMILTON COUNTY UPGRADE</p>	
DRAWN BY: RICHARD SMITH	DATE: 08/09/2004
APPROVED BY: RICHARD SMITH	DATE: 08/09/2004
APPROVED BY:	DATE:
PROJECT NUMBER: 288-401749 855790001	
SHEET TITLE: FIRE ALARM THIRD FLOOR	
SHEET NUMBER: FF02-A	

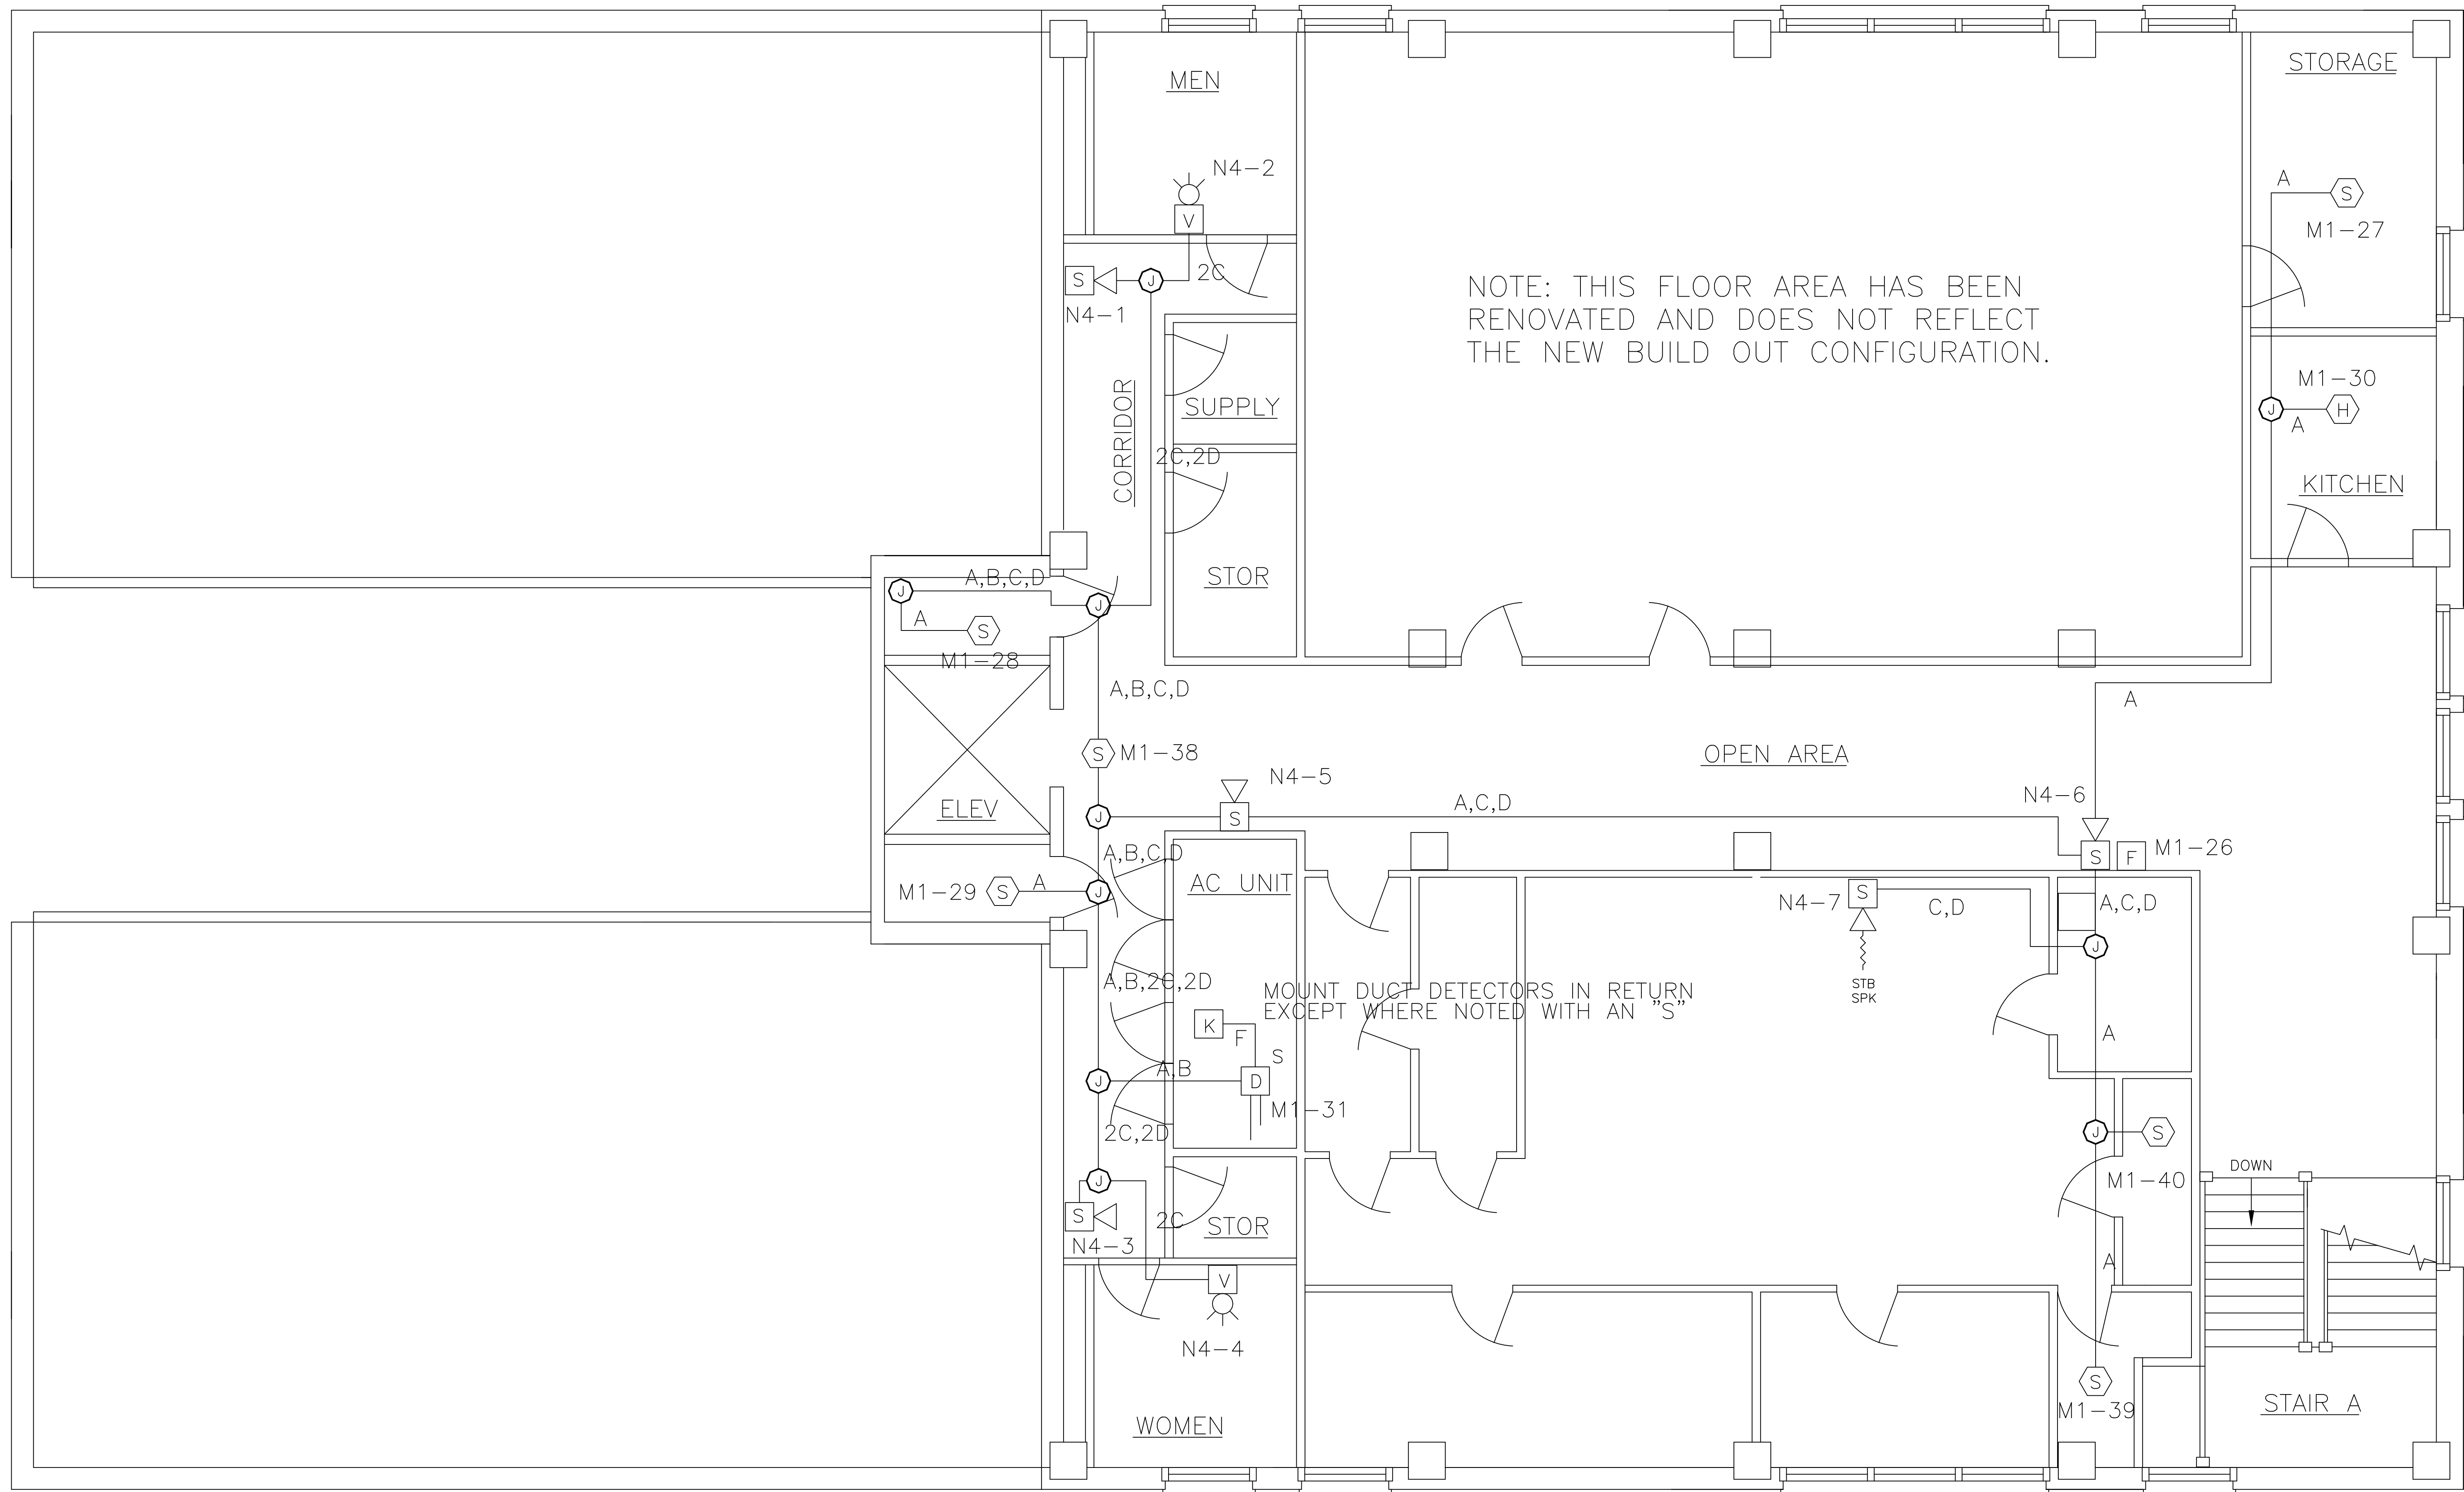

FOURTH FLOOR PLAN

AS-BUILT  
 RECORD  
 DRAWING  
 10/11/2004

**tyco** / Fire & Security / **SimplexGrinnell**  
 3200 N. HAYTHORNE STREET  
 CHATTANOOGA, TN. 37406  
 SALES: 423-698-4418  
 SERVICE: 423-698-4118  
 FAX: 423-698-5979  
 © 2001 HAMILTON COUNTY BOARD OF  
 ALL RIGHTS RESERVED

NO.	DATE	REVISION DESCRIPTION

FIRE ALARM SYSTEM  
 MILK BUILDING  
 317 OAK STREET  
 CHATTANOOGA, TN. 37402  
 HAMILTON COUNTY UPGRADE

DRAWN BY: RICHARD SMITH      DATE: 08/09/2004  
 APPROVED BY: RICHARD SMITH      DATE: 08/09/2004  
 APPROVED BY:      DATE:

PROJECT NUMBER:  
 288-401749  
 855790001

SHEET TITLE:  
 FIRE ALARM  
 FOURTH FLOOR

SHEET NUMBER:  
 FF02-B